



5014 ABRAMS RD

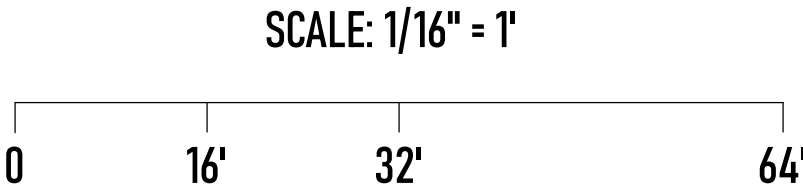

NOTE: PROPERTY BOUNDARY RECONSTRUCTED FROM SURVEY (VERIFY)

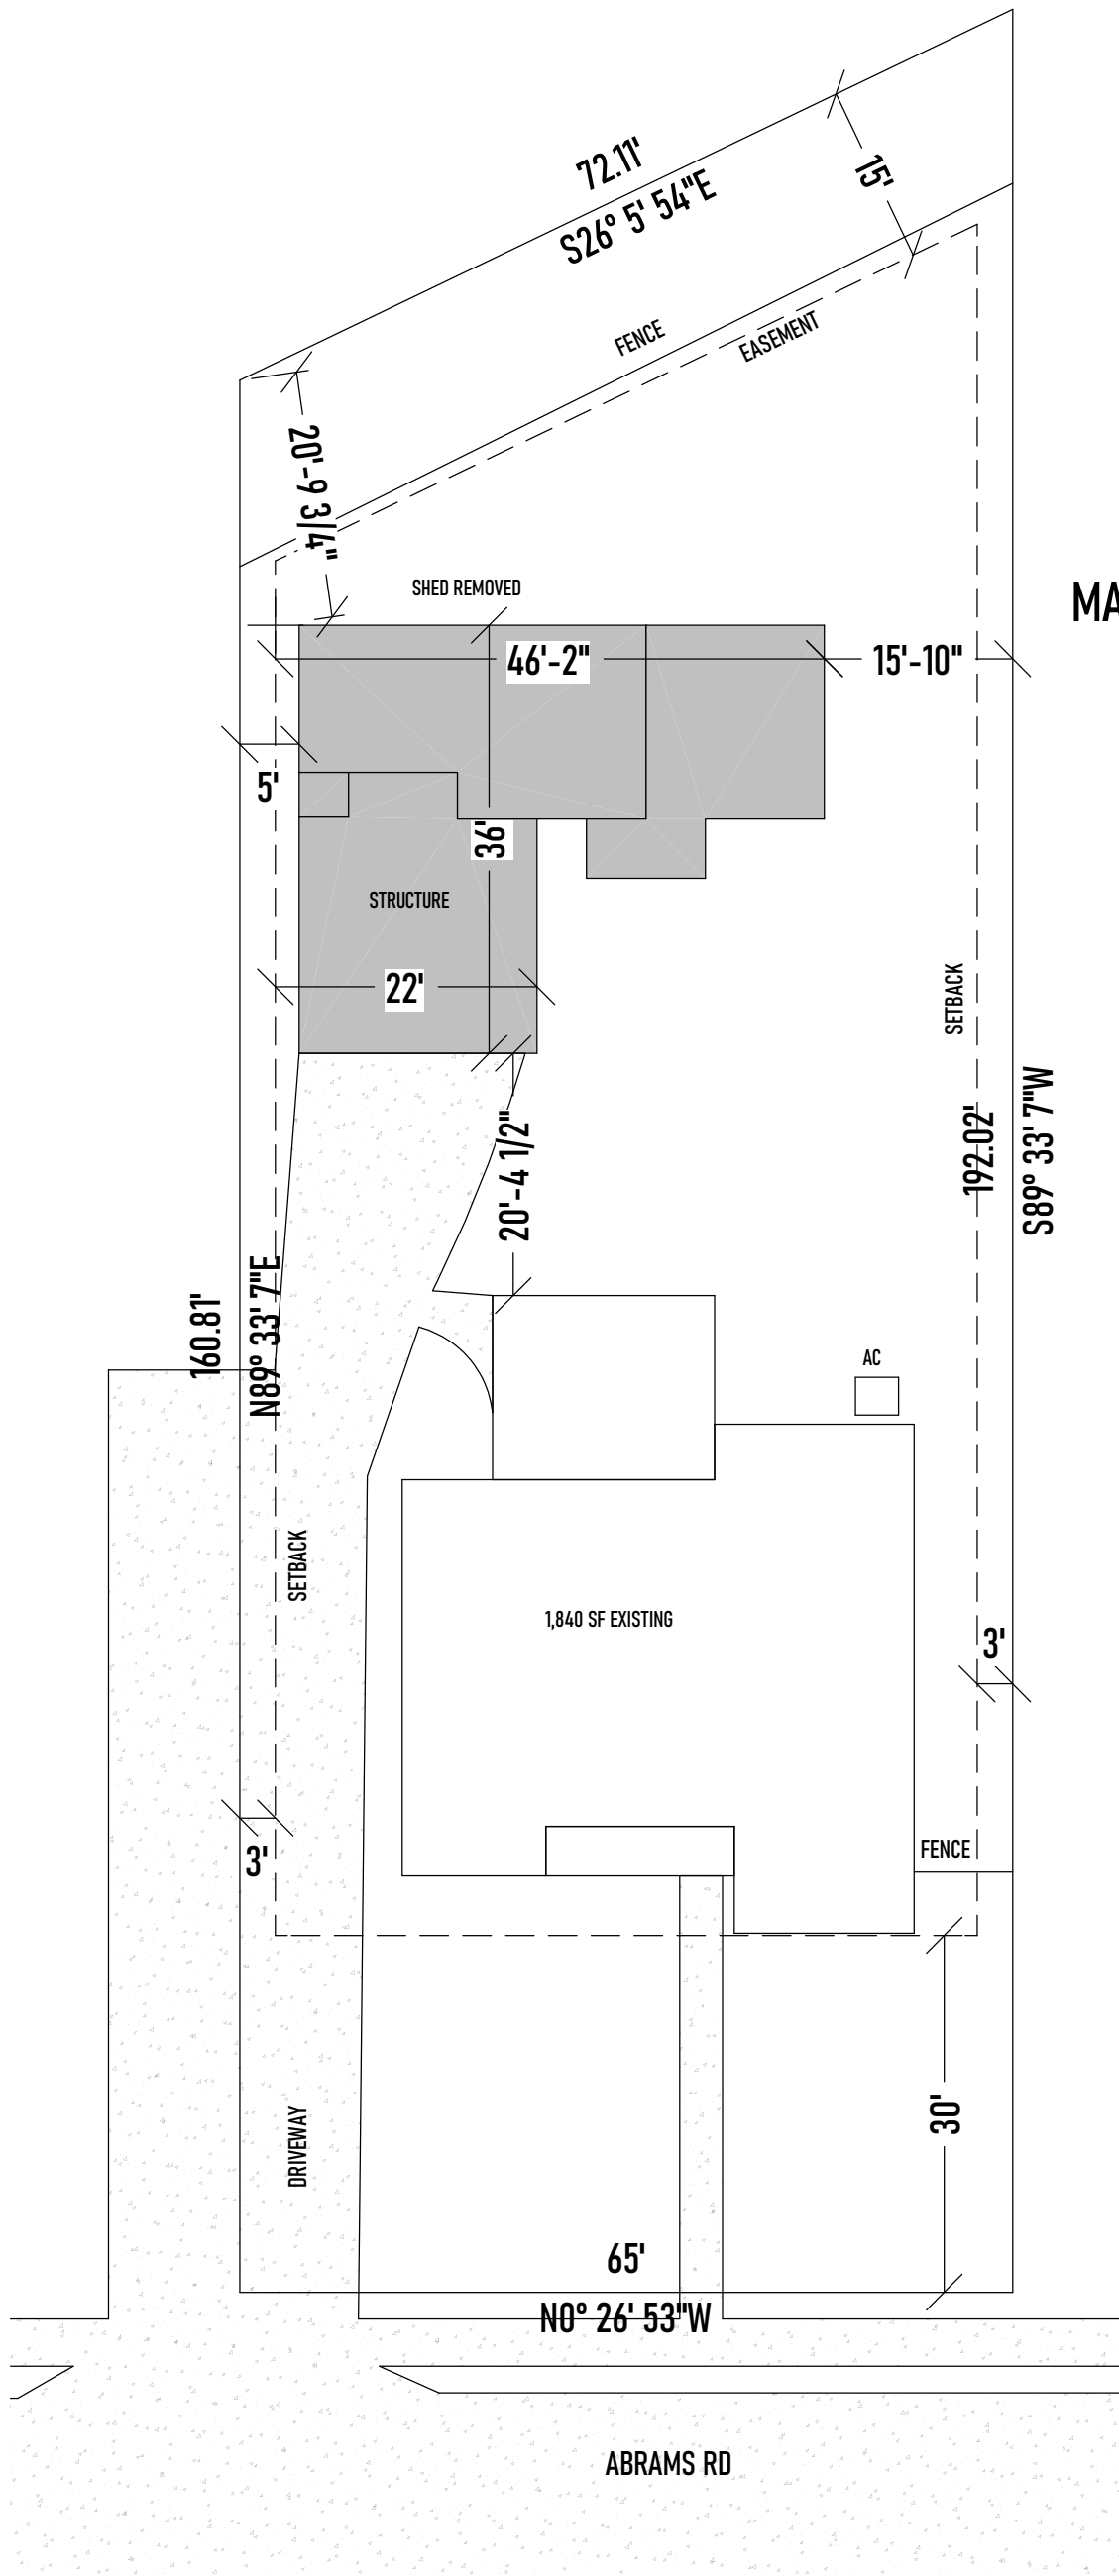

MAIN HOUSE: 1,498 SQFT MAIN HOUSE +345 SQFT OF COVERED PATIO/ PORCHES= 1,840 SQFT

TOTAL FOOTAGES

TOTAL LIVING: 423 SF

PATIO: 294 SF

GARAGE: 446 SF

TOTAL SLAB: 1,163 SF

SHEET NAME	SHEET NO.
SITE PLAN	A1.00
FLOORPLAN	A2.00
ELECTRICAL LAYOUT	A3.00
ELEVATIONS	A4.00
ROOF LINES	A5.00
SLAB LAYOUT	S1.00
QUANTITIES	Q1.00

SHEET INDEX

5014 ABRAMS RD	SITE PLAN
DRAWN BY:  RAPID DESIGNS WWW.RAPIDARCHITECTURAL.COM	
SHEET: A1.00	